


SYMBOL LEGEND		
	LOGICO2 MK9 CO2 SENSOR	6 EACH
	LOGICO2 MK9 O2 SENSOR	2 EACH
	LOGICO2 CENTRAL UNIT	1 EACH
	LOGICO2 TRAFFIC LIGHT	3 EACH
	LOGICO2 HORN / STROBE	10 EACH
	LOGICO2 SNIFFER BLUE TOOTH	2 EACH
	LOGICO2 POWER MONITOR	1 EACH
	LOGICO2 SMB SHUT OFF VALVE	1 EACH

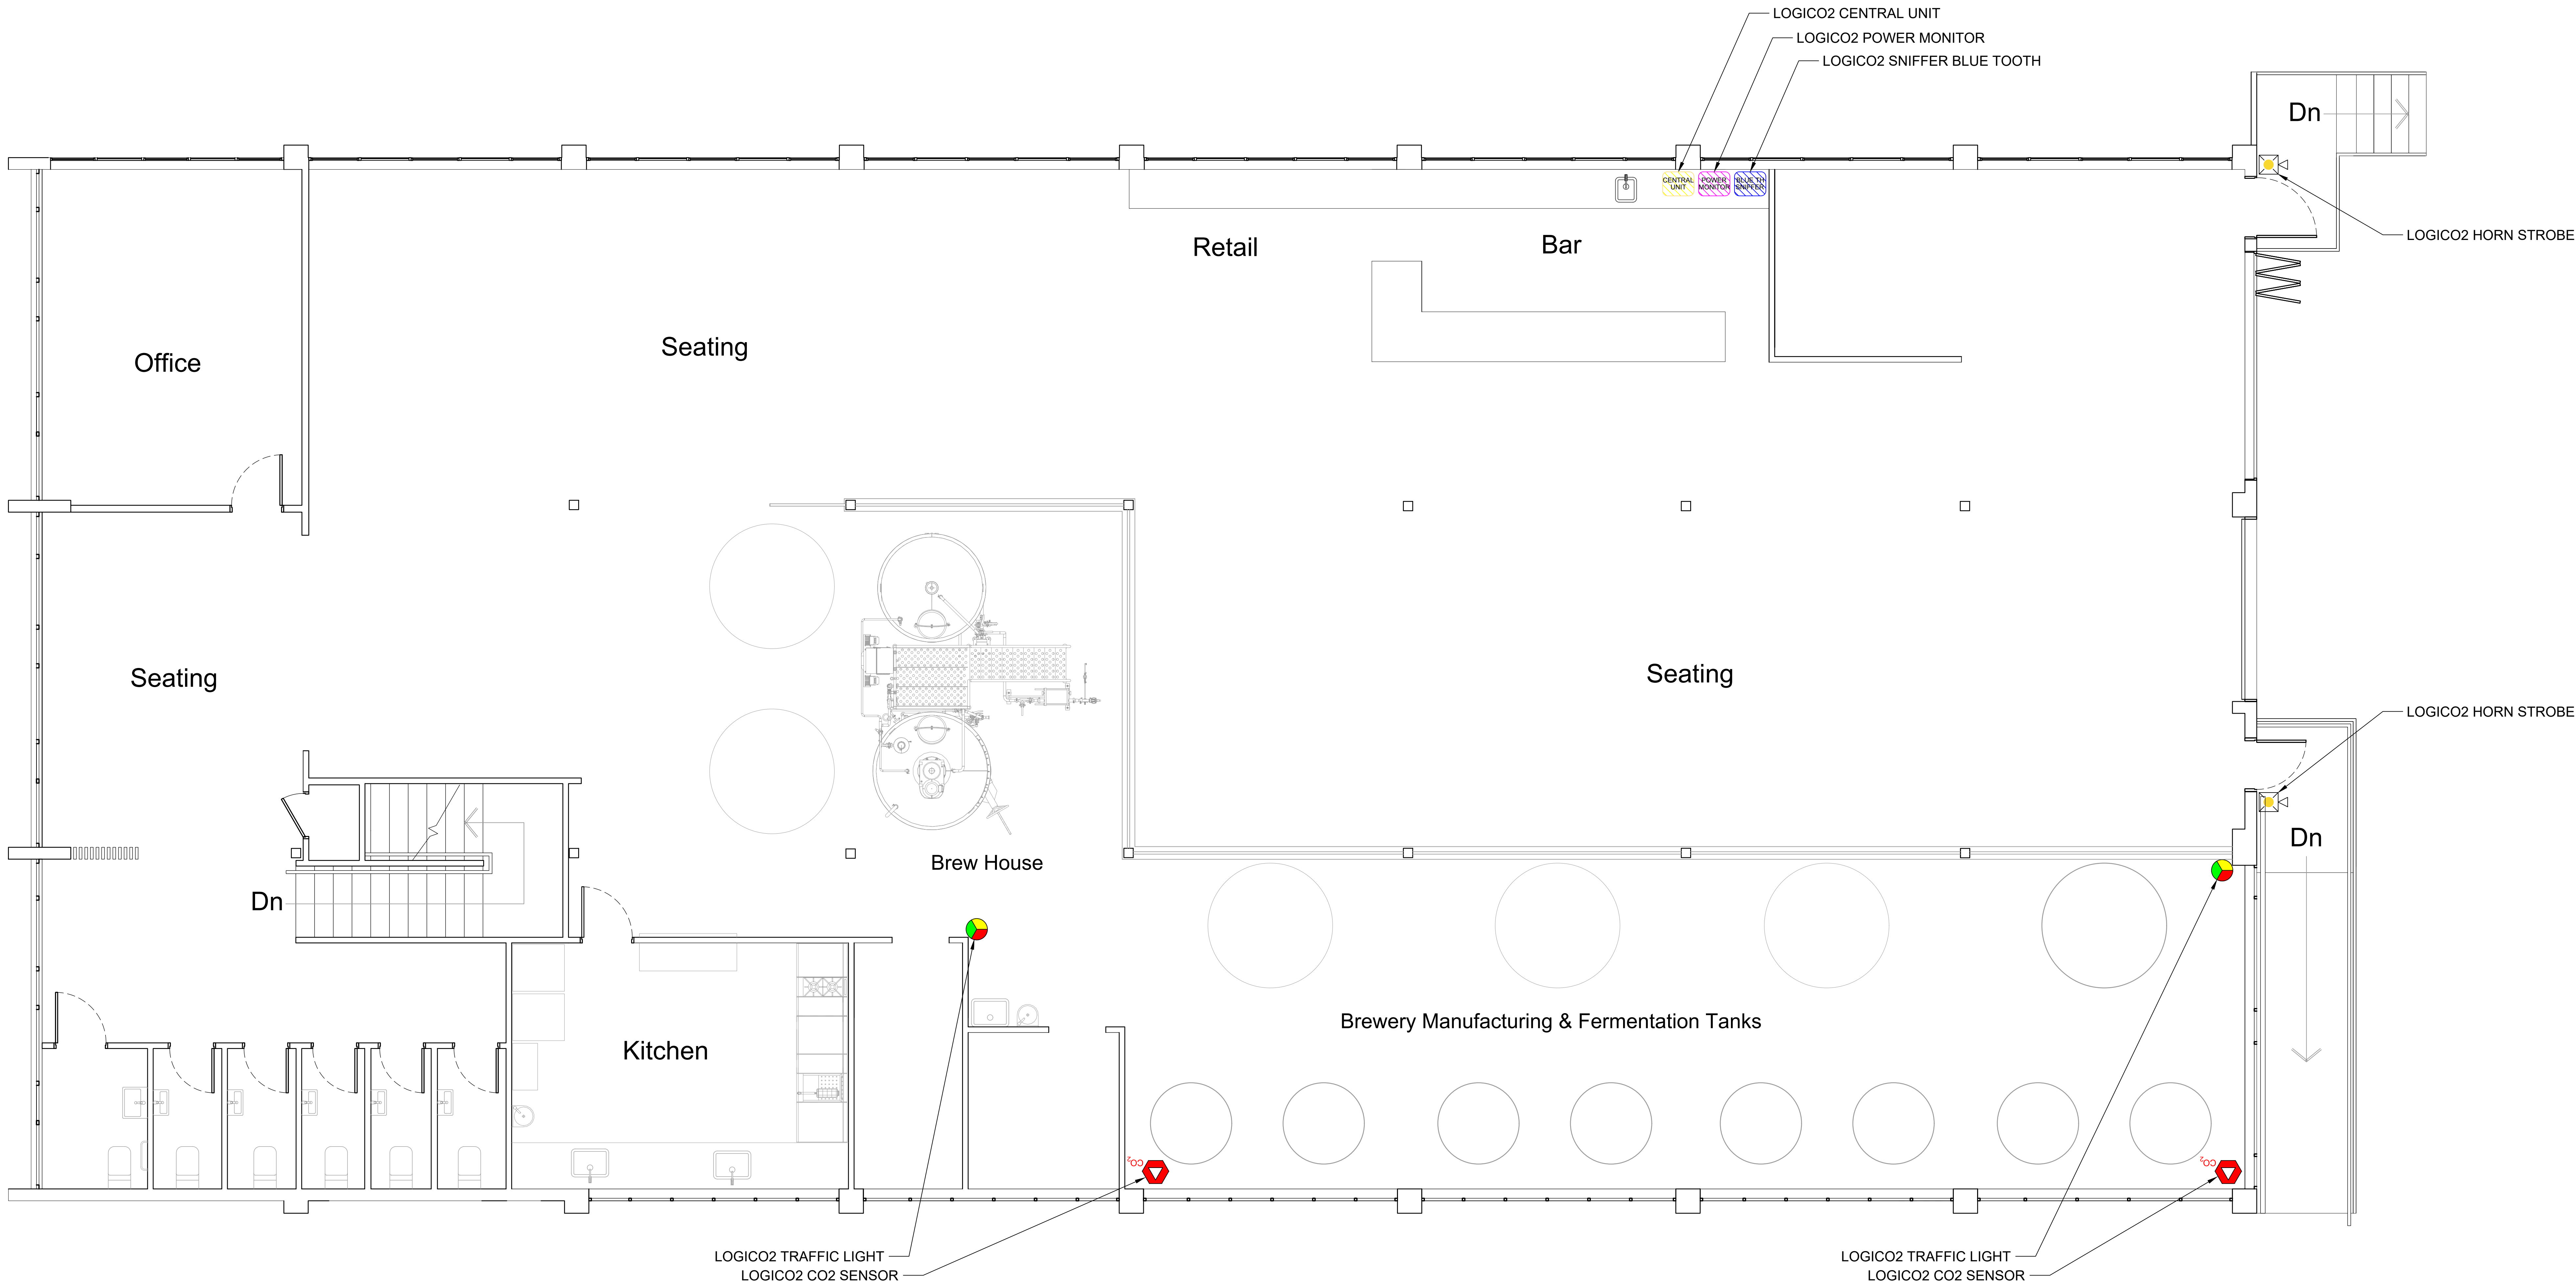

URBANAUT BREWERY AND TAPROOM

597 NEW NORTH ROAD
KINGSLAND, AUCKLAND 1021, NEW ZEALAND

NORTH

SITE PLAN
SCALE 1:40

PREPARED BY:
ROSS OLSEN
ross.olsen@logico2.com
719-877-2282




ISSUES/REVISIONS	
DATE	DESCRIPTION
12 JAN 26	INITIAL

SHEET TITLE
CARBON DIOXIDE
CONTROL AND
DETECTION SYSTEM

UPPER FLOOR

SHEET NUMBER

SYMBOL LEGEND		
	LOGICO2 MK9 CO2 SENSOR	6 EACH
	LOGICO2 MK9 O2 SENSOR	2 EACH
	LOGICO2 CENTRAL UNIT	1 EACH
	LOGICO2 TRAFFIC LIGHT	3 EACH
	LOGICO2 HORN / STROBE	10 EACH
	LOGICO2 SNIFFER BLUE TOOTH	2 EACH
	LOGICO2 POWER MONITOR	1 EACH
	LOGICO2 SMB SHUT OFF VALVE	1 EACH

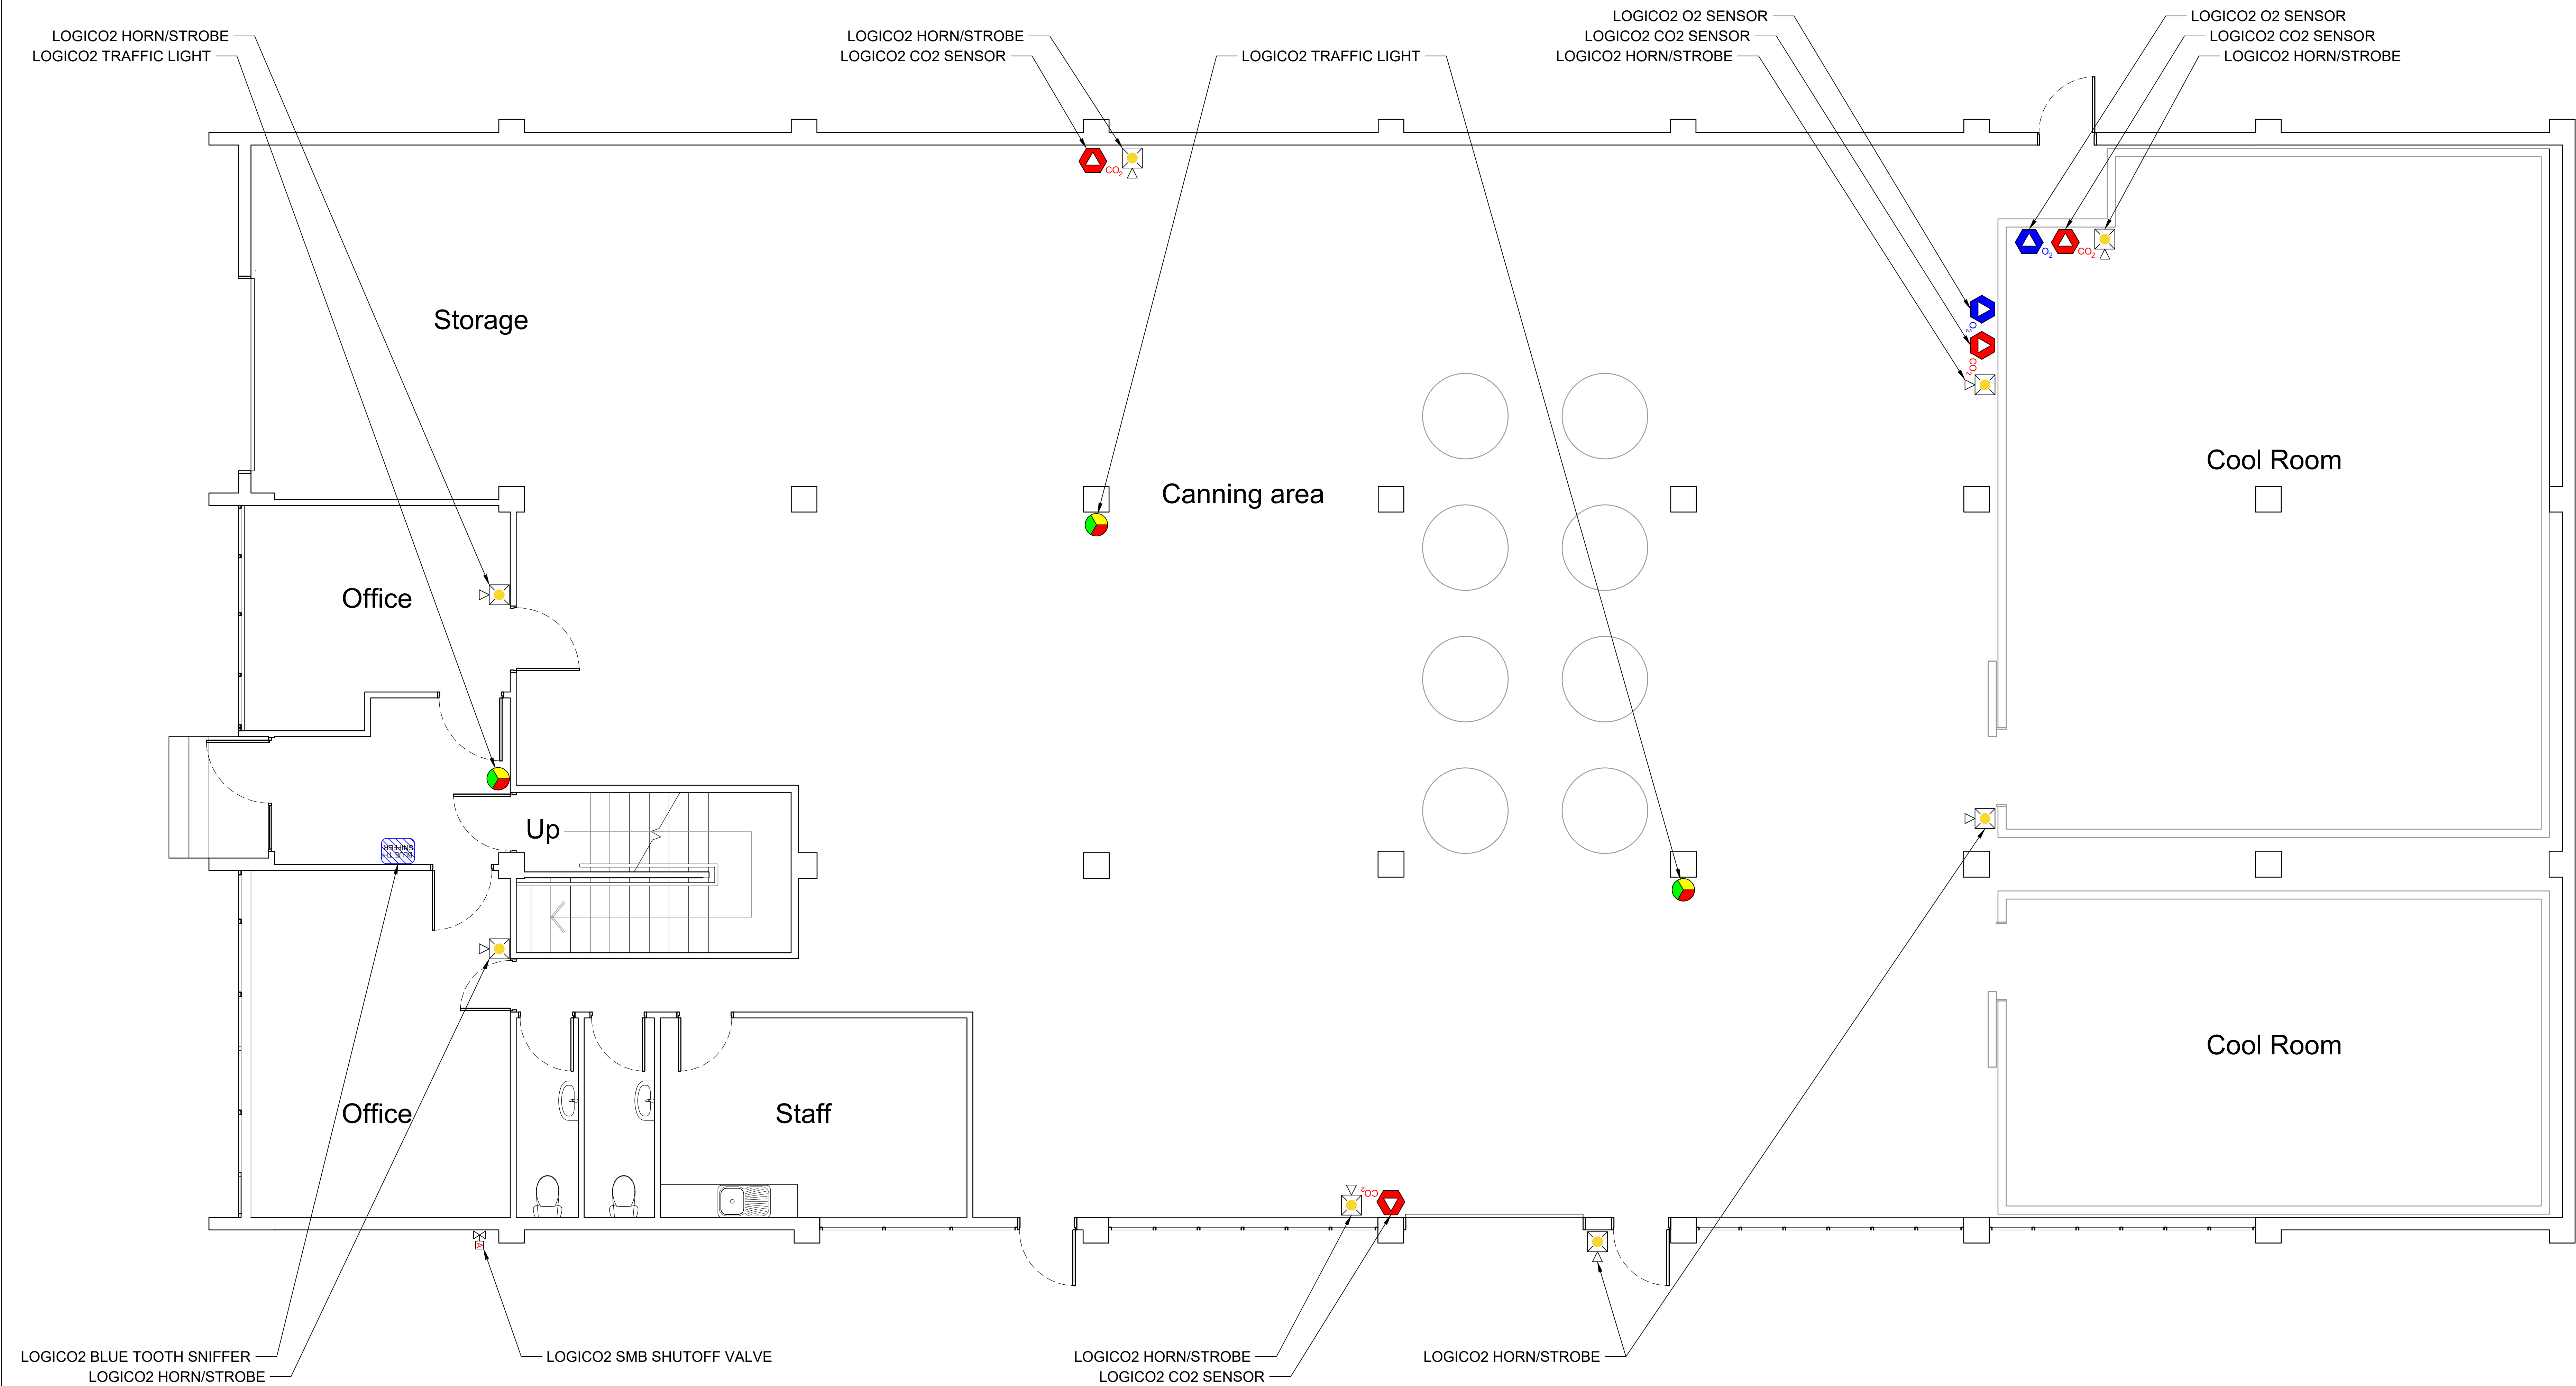

URBANAUT BREWERY AND TAPROOM

597 NEW NORTH ROAD
KINGSLAND, AUCKLAND 1021, NEW ZEALAND

NORTH

SITE PLAN
SCALE 1:40

PREPARED BY:
ROSS OLSEN
ross.olsen@logico2.com
719-877-2282



ISSUES/REVISIONS	
DATE	DESCRIPTION
12 JAN 26	INITIAL

SHEET TITLE
CARBON DIOXIDE
CONTROL AND
DETECTION SYSTEM

LOWER FLOOR

SHEET NUMBER